 



LOCALITY PLAN  
SCALE 1:2500 MAP GRID NO. J10



SR 8/87 (DECLARED)  
SR 78/91 (DECLARED)  
SR 80/88 (DECLARED)

EXAMPLE ONLY

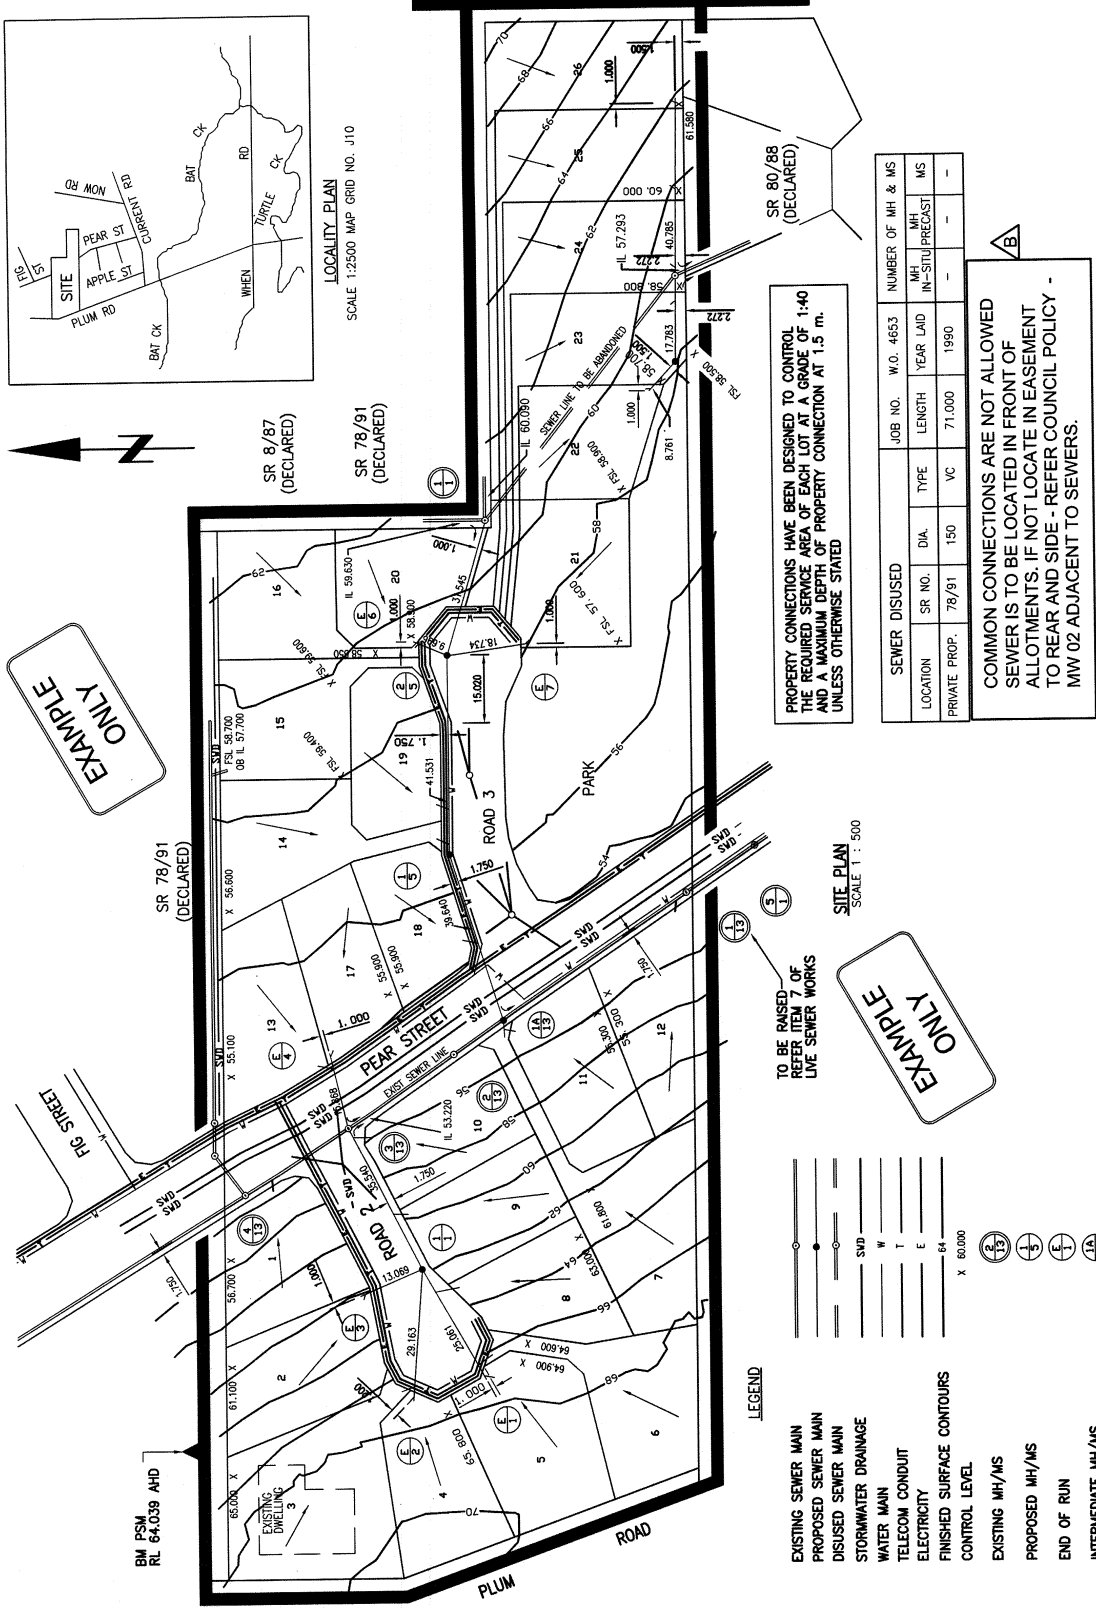

PROPERTY CONNECTIONS HAVE BEEN DESIGNED TO CONTROL THE REQUIRED SERVICE AREA OF EACH LOT AT A GRADE OF 1:40 AND A MAXIMUM DEPTH OF PROPERTY CONNECTION AT 1.5 m. UNLESS OTHERWISE STATED

SEWER DISUSED		JOB NO.	W.O.	4653	NUMBER OF MH & MS	
LOCATION	SR NO.	DIA.	TYPE	LENGTH	YEAR LAID	MS
PRIVATE PROP.	78/91	150	VC	71.000	1990	-

COMMON CONNECTIONS ARE NOT ALLOWED SEWER IS TO BE LOCATED IN FRONT OF ALLOTMENTS. IF NOT LOCATE IN EASEMENT TO REAR AND SIDE - REFER COUNCIL POLICY - MW 02 ADJACENT TO SEWERS.

SITE PLAN  
SCALE 1 : 500

TO BE RAISED REFER ITEM 7 OF LIME SEWER WORKS

EXAMPLE ONLY

LEGEND

- EXISTING SEWER MAIN
- PROPOSED SEWER MAIN
- DISUSED SEWER MAIN
- STORMWATER DRAINAGE
- WATER MAIN
- TELECOM CONDUIT
- ELECTRICITY
- FINISHED SURFACE CONTOURS
- CONTROL LEVEL
- EXISTING MH/MS
- PROPOSED MH/MS
- END OF RUN
- INTERMEDIATE MH/MS

<b>Mackay REGIONAL COUNCIL</b>		STANDARD DRAWING DESIGN LAYOUTS TYPICAL LOCALITY & SITE PLAN		DRAWING No. <b>A3-04196</b> AMEND. <b>C</b>		SHEET 1 OF 1	
<b>COMMERCIAL SERVICES</b>		EXECUTIVE MANAGER MACKAY WATER & WASTE RPEQ 7506  <b>JASON DEVITT</b>		DATE <b>27 MAY09</b>			
DRAWING FILE NAME <small>M:\Engineering Services\Technical Services\Design\Projects\Standard Drawings\Mackay Water\WSAA-MRC\SEW CODE\A3-04196B</small>		WSAA NO. <b>SEW-1100</b>		DATE OF LAST EDIT May 21, 2009		JOB No	
<b>C S/D</b> <b>AMEND</b> <b>MGR</b> <b>SGN.</b>		SURVEY N/A		SURVEY FILE No N/A		LEVEL DATUM A.H.D.	
B MAY08 NOT TO BE USED		SURVEY N/A		SURVEY FILE No N/A		MERIDIAN MGA-65	
A OCT07 T'SFER TO MRC TBLOCK		SURVEY N/A		SURVEY FILE No N/A		APPVD.	
O WSSA ORIG.		SURVEY N/A		SURVEY FILE No N/A		DESCRIPTION	
NO. DATE		SURVEY N/A		SURVEY FILE No N/A		APPVD.	

MRC STANDARD DRAWINGS SUPERCEDES WSAA STANDARD DRAWINGS