



TYPE OF DISPOSAL AREA INSTALLED
EG. ABSORPTION, IRRIGATION ETC.

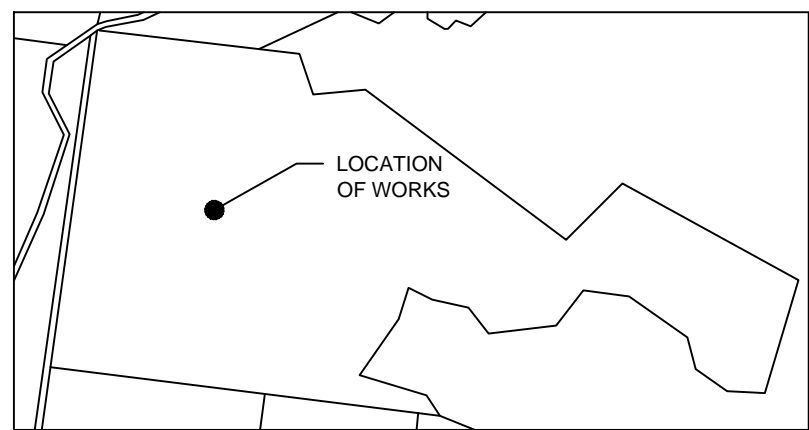

SITE LOCATION
NOT TO SCALE

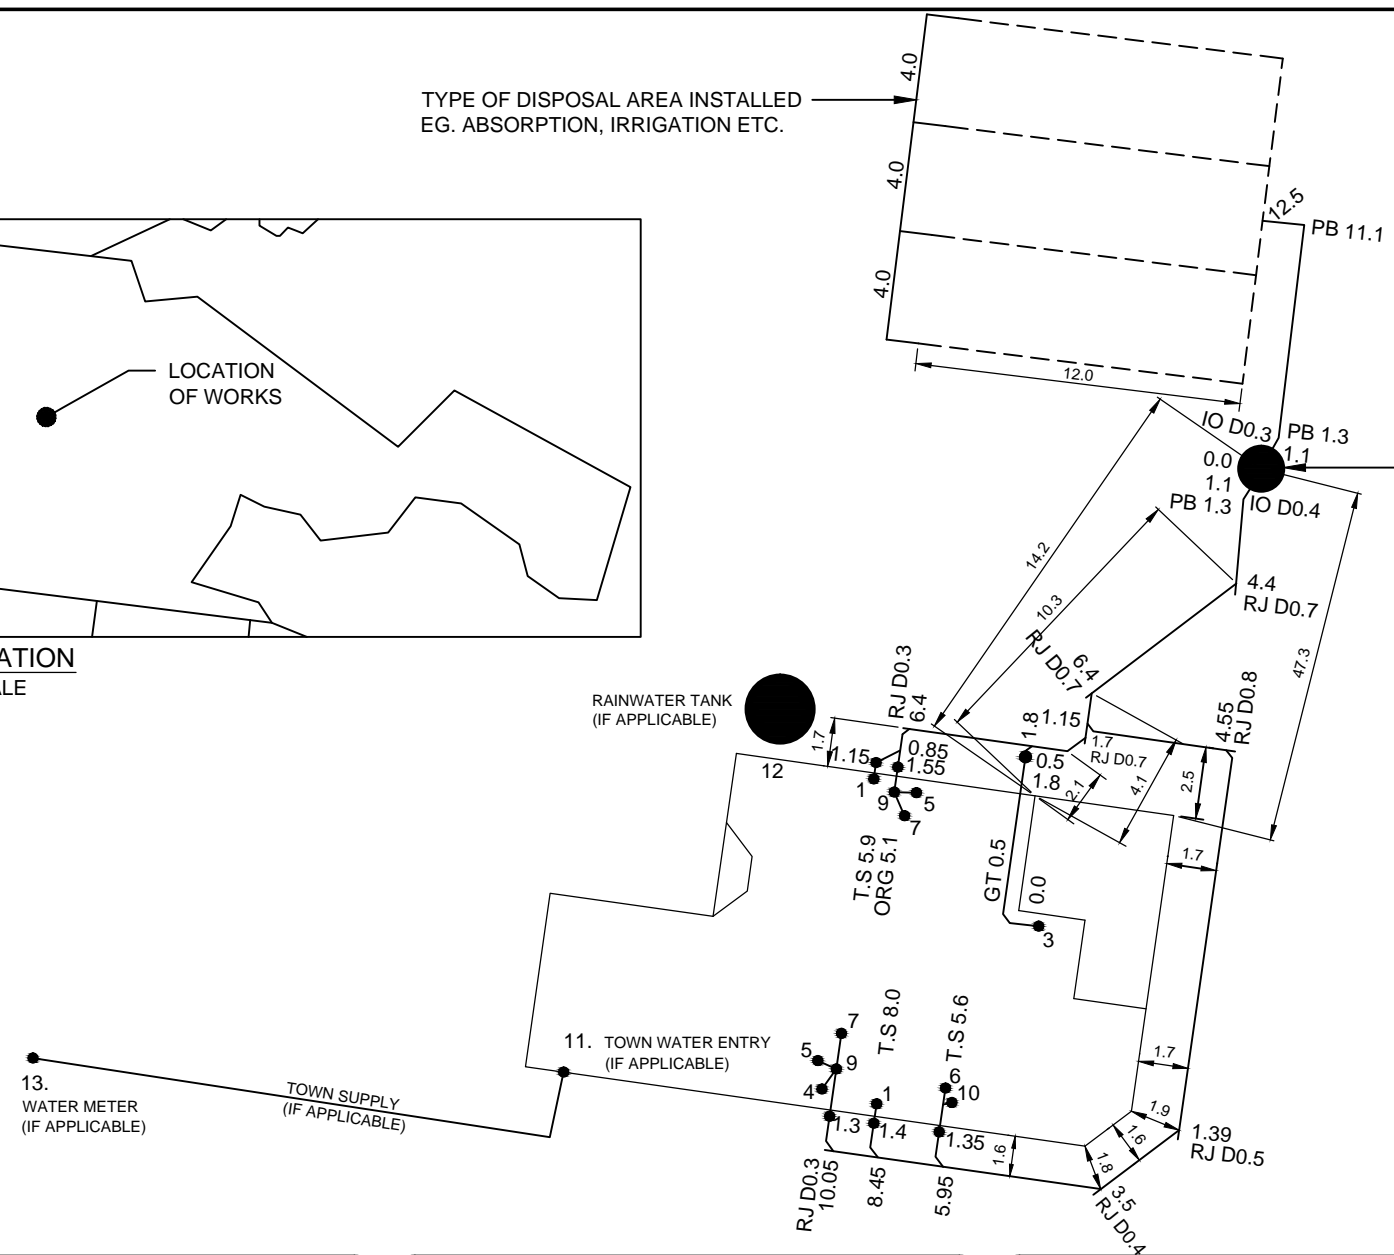

TYPE OF TREATMENT
SYSTEM INSTALLED

SAMPLE ONLY

DESIGNED BY:
DRAWN BY:
PLUMBER:
DEVELOPMENT PERMIT No: ST #####
DATE: DD/MM/YYYY

LEGEND		
1. W.C.	6. TUBS	11. TOWN WATER ENTRY POINT
2. URINAL	7. SHOWER	12. TANK WATER ENTRY POINT
3. SINK	8. SPA	13. WATER METER
4. BATH	9. F.W.G.	14. HCB (JUMP UP)
5. BASIN	10. VENT	

AS CONSTRUCTED WATER SUPPLY, UNDER
SLAB & DRAINAGE PLAN (NON SEWERED AREA)
ADDRESS: ## STREET NAME
SUBURB: NAME
LOT & PLAN: L## ON RP#####

ST #####
REVISION #
SCALE 1:200
SHEET 1 OF 2